


**WASTEWATER STANDARD DRAWINGS:**

THIS DRAWING SHALL BE READ IN CONJUNCTION WITH THE FOLLOWING IRISH WATER STANDARD DRAWINGS.


- WASTEWATER STANDARD DRAWINGS**
- STD-WW-01 WASTEWATER SERVICE CONNECTION RESPONSIBILITY
  - STD-WW-02 TYPICAL LAYOUT FOR SEWER WITHIN NEW DEVELOPMENTS
  - STD-WW-03 DRAIN AND SERVICE CONNECTION PIPEWORK
  - STD-WW-04 TYPICAL SEWER / SERVICE PIPE CONNECTION
  - STD-WW-05 TYPICAL SERVICE LAYOUT INDICATING SEPARATION DISTANCES
  - STD-WW-06 RESTRICTIONS ON TREES / SHRUBS PLANTING ADJACENT TO SEWERS
  - STD-WW-07 TRENCH BACKFILL AND BEDDING
  - STD-WW-08 CONCRETE BED, HAUNCH AND SURROUND TO WASTEWATER PIPES
  - STD-WW-09 BLOCKWORK MANHOLE (<450mm DIA)
  - STD-WW-10 PRE-CAST CONCRETE MANHOLE
  - STD-WW-11 IN-SITU CONCRETE MANHOLE
  - STD-WW-12 BACKDROP MANHOLES
  - STD-WW-13 PRIVATE SIDE INSPECTION CHAMBER

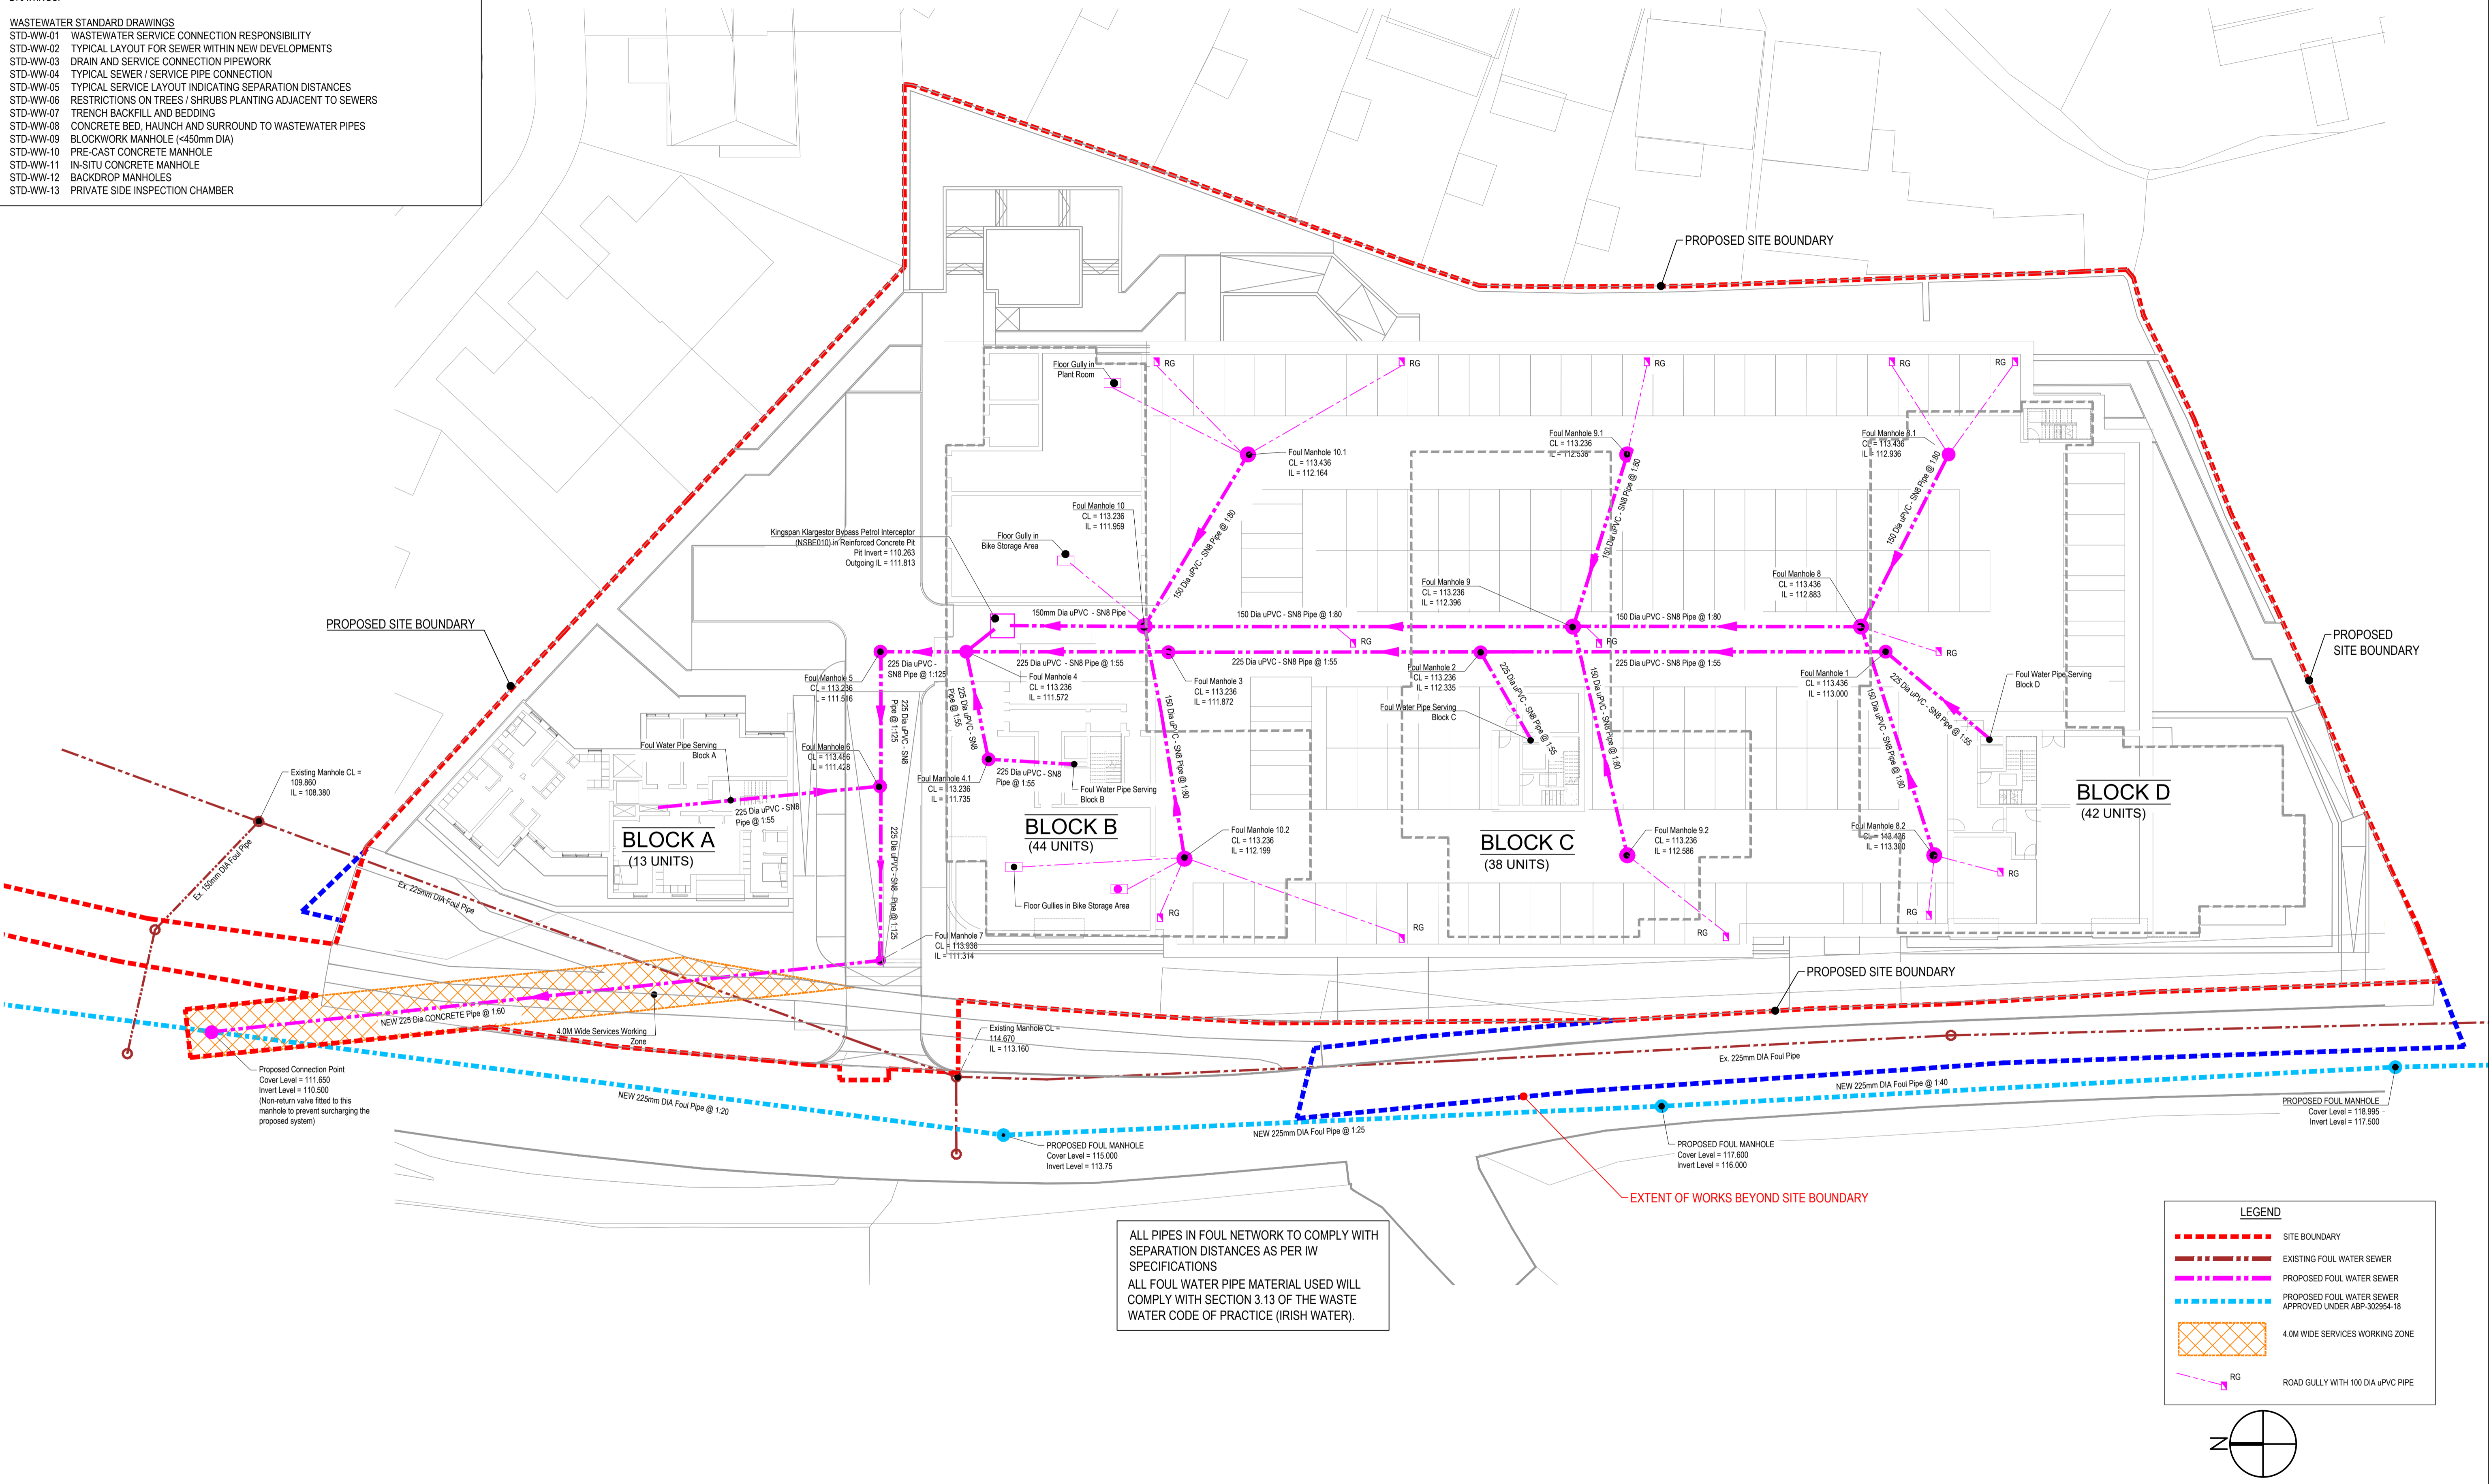

ALL PIPES IN FOUL NETWORK TO COMPLY WITH SEPARATION DISTANCES AS PER IW SPECIFICATIONS  
 ALL FOUL WATER PIPE MATERIAL USED WILL COMPLY WITH SECTION 3.13 OF THE WASTE WATER CODE OF PRACTICE (IRISH WATER).

**LEGEND**

- - - - - SITE BOUNDARY
- - - - - EXISTING FOUL WATER SEWER
- - - - - PROPOSED FOUL WATER SEWER
- - - - - PROPOSED FOUL WATER SEWER APPROVED UNDER ABP-302954-18
- 4.0M WIDE SERVICES WORKING ZONE
- - - - - RG ROAD GULLY WITH 100 DIA uPVC PIPE

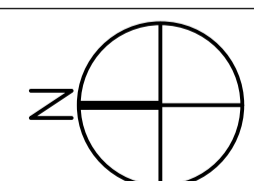

**Notes:**  
 For setting out refer to Architect's drawings.  
 This drawing shall be read in conjunction with all other Architectural and Engineering drawings and all other relevant drawings and Specifications.  
 DO NOT SCALE FROM THIS DRAWING. Use figured dimensions only.  
 Verify dimensions on site and report any discrepancies to the author immediately.  
 This drawing is copyright © and must not be reproduced, transmitted or stored in any form without the written permission of Torque Consulting Engineers Limited except as agreed for use on the project for which the document was originally issued.

Rev	Dm	Chkd	Amendments	Date
P06	DG	AS	ISSUED FOR PLANNING	22/04/2022
P05	DG	AS	ISSUED FOR PLANNING	20/04/2022
P04	OM	AS	ISSUED FOR PLANNING	11/04/2022
P03	OM	AS	ISSUED FOR PLANNING	28/03/2022
P02	OM	AS	ISSUED FOR PLANNING	17/09/2021
P01	OM	AS	ISSUED FOR PLANNING	06/09/2021

Rev	Dm	Chkd	Amendments	Date

<b>FOR PLANNING</b>	
Drawing Sheet Size	A1

Architect HORAN RAINSFORD ARCHITECTS	
Project SANDYFORD ROAD SHD	
Title SITE DRAINAGE - PROPOSED FOUL WATER DRAINAGE LAYOUT	
Drg No : S047-TCE-ZZ-ZZ-DR-C-0001	Revision : P06
Scale : 1:250	Date : 06/08/2021
Dm By : OM	Chkd By : AS
	Aprvd By : KM

**TORQUE CONSULTING ENGINEERS**  
 CIVIL & STRUCTURAL

3rd Floor  
 The Glasshouse  
 11 Coke Lane  
 Dublin 7  
 D07 WNP2  
 Ireland

T: +353 (0)1 4853933  
 E: contactus@tce.ie  
 W: www.tce.ie